



GREENWOOD COMMISSIONERS OF PUBLIC WORKS

**CDBG WATERLINE UPGRADE-SOUTHEAST  
CITY OF GREENWOOD-CDBG PROJ. NO. 4-CI-11-012**

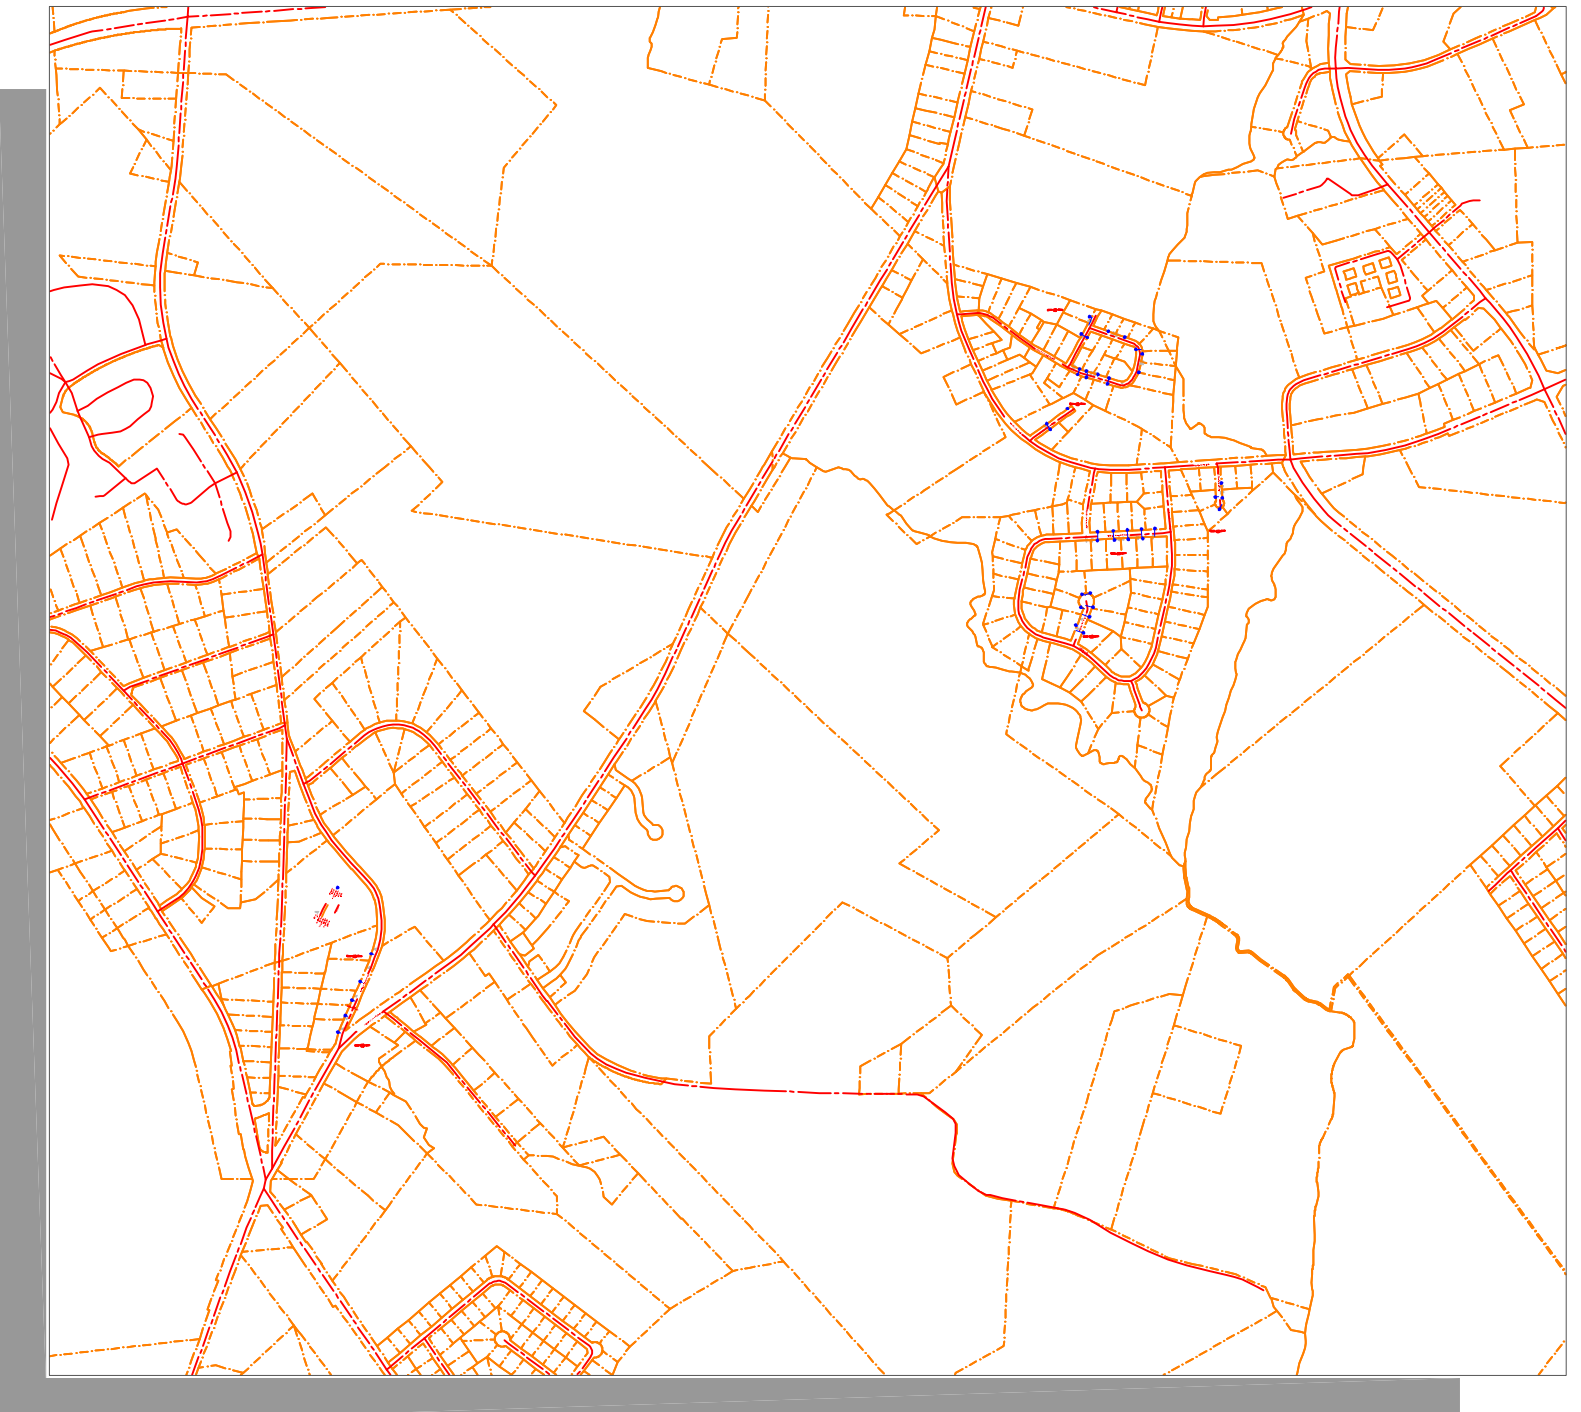

LOCATION CDBG PROJECT  
N.T.S.

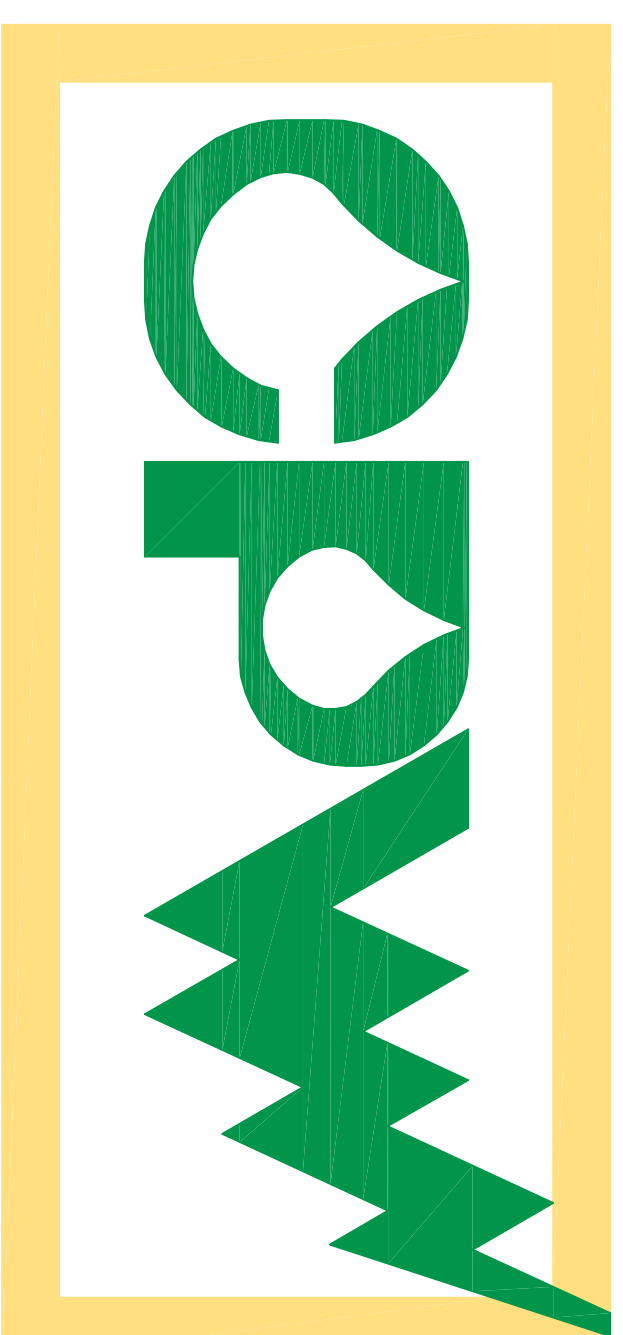

AUGUST 2011

SHEET NO.	DESCRIPTION
L-1	KEY MAP & GENERAL NOTES
PV-1	PLAN VIEW
PV-2	PLAN VIEW
PV-3	PLAN VIEW
PV-4	PLAN VIEW
D-1	SEDIMENT AND EROSION CONTROL DETAILS
D-2	GENERAL DETAILS
D-3	GENERAL DETAILS